

16' x 9' =

20' x 9' 7.5" = 195  
16' 6" x 31' 6" = 516  
195 = 36 = 75  
158 = 26


20' x 10' = 200

Zone C. 144

Zone B. 158

Zone A. 200

20' x 10' = 200  
795  
360  
31.5

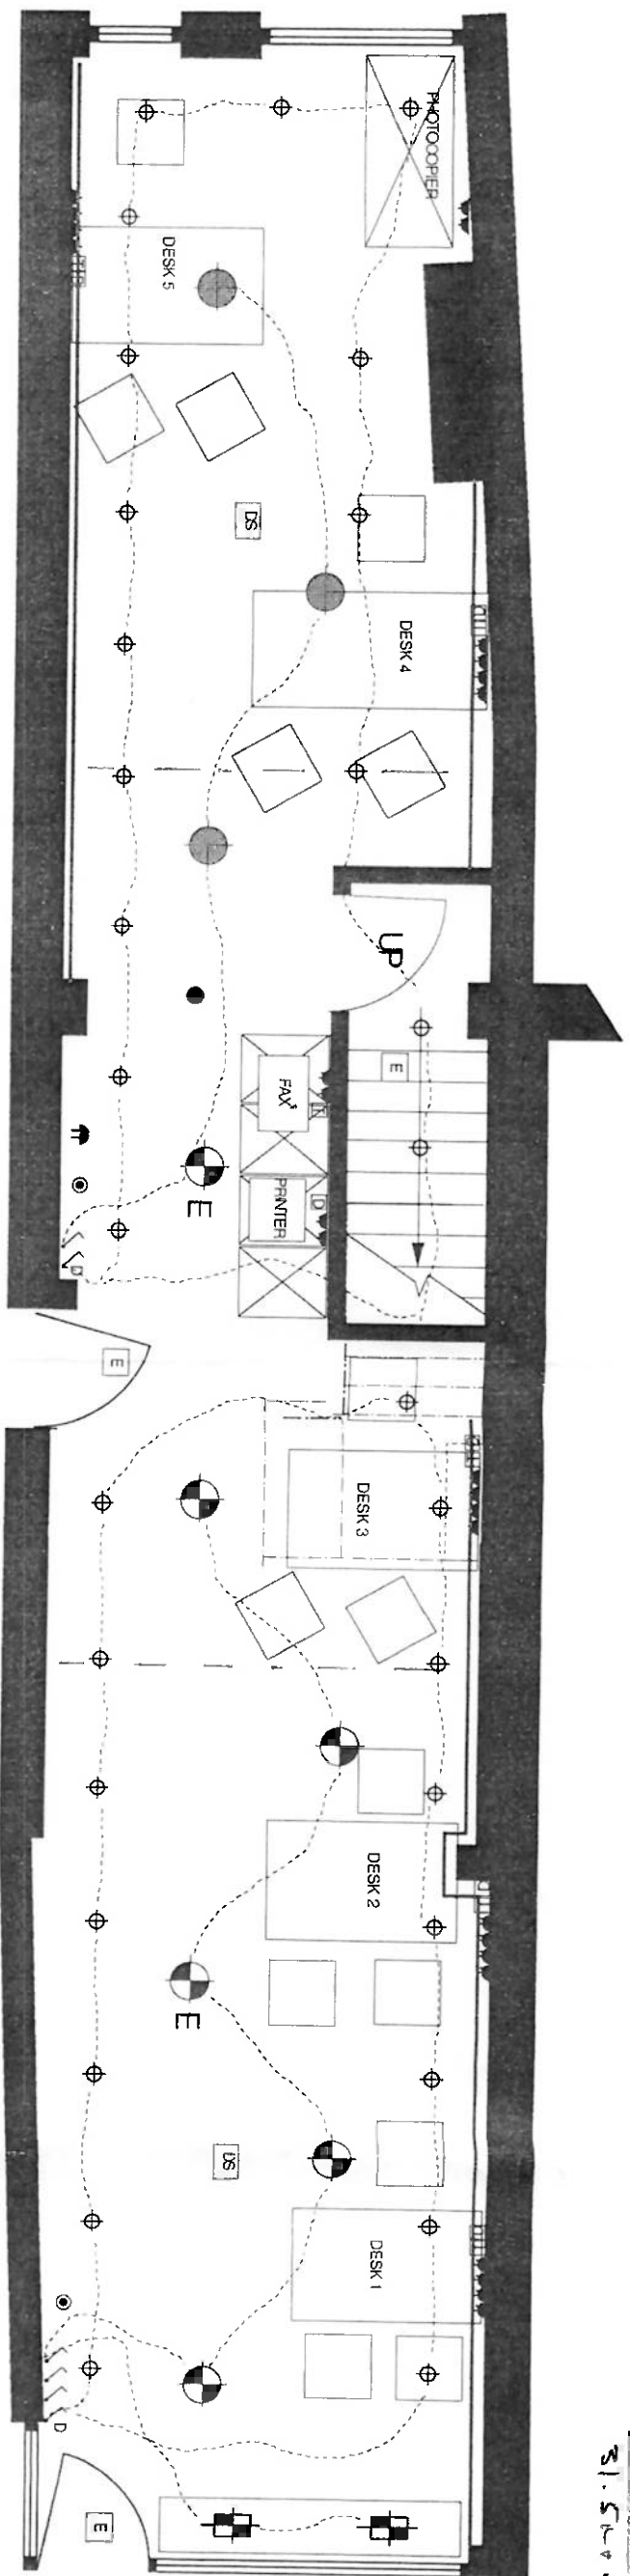

- ELECTRICAL KEY
- 3 COMPARTMENT SKIPPING TRUNKING
  - RECESSED WHITE METAL HALIDES
  - EMERGENCY COMPACT FLUORESCENT
  - COMPACT FLUORESCENT CAT 2
  - EMERGENCY BRICK LIGHT
  - SURFACE MOUNTED ELIPSE FITTINGS
  - DIRECTIONAL MONDIAL LV RECESSED FITTINGS
  - ONE WAY LIGHT SWITCH
  - DIMMER LIGHT SWITCH

- F FUSED NEON SPUR
- FF FIRE ALARM SQUINDER
- DS FIRE ALARM SMOKE DETECTOR
- CP CALL POINT (BREAK GLASS)
- ES EXISTING SURFACE MOUNTED LAMPS

NB FIRE INSPECTOR TO ADVISE ON FIRE EXTINGUISHERS AND FIRE ALARM SYSTEM

FIELDWORK  
DESIGN CONSULTANTS

PROSPECT PLACE  
HEATHFIELD TERRACE  
LONDON W4 4JE

Email: fieldwork.co.uk  
FAX: +44 (0)181 747 1560  
TEL: +44 (0)181 994 9246

SCALES: 1:50

DRAWN BY: DOF


DATE: 10.3.99

DRAWING TITLE: PROPOSED GROUND FLOOR GENERAL M&E PLAN

PROJECT: HAMPTONS INTERNATIONAL, 27 EAST STREET, CHICHESTER

NOTES: Dimensions shall not be scaled from this drawing. All figured dimensions must be verified on site. Discrepancies are to be notified immediately to the designee.

© THIS DRAWING IS THE COPYRIGHT OF FIELDWORK

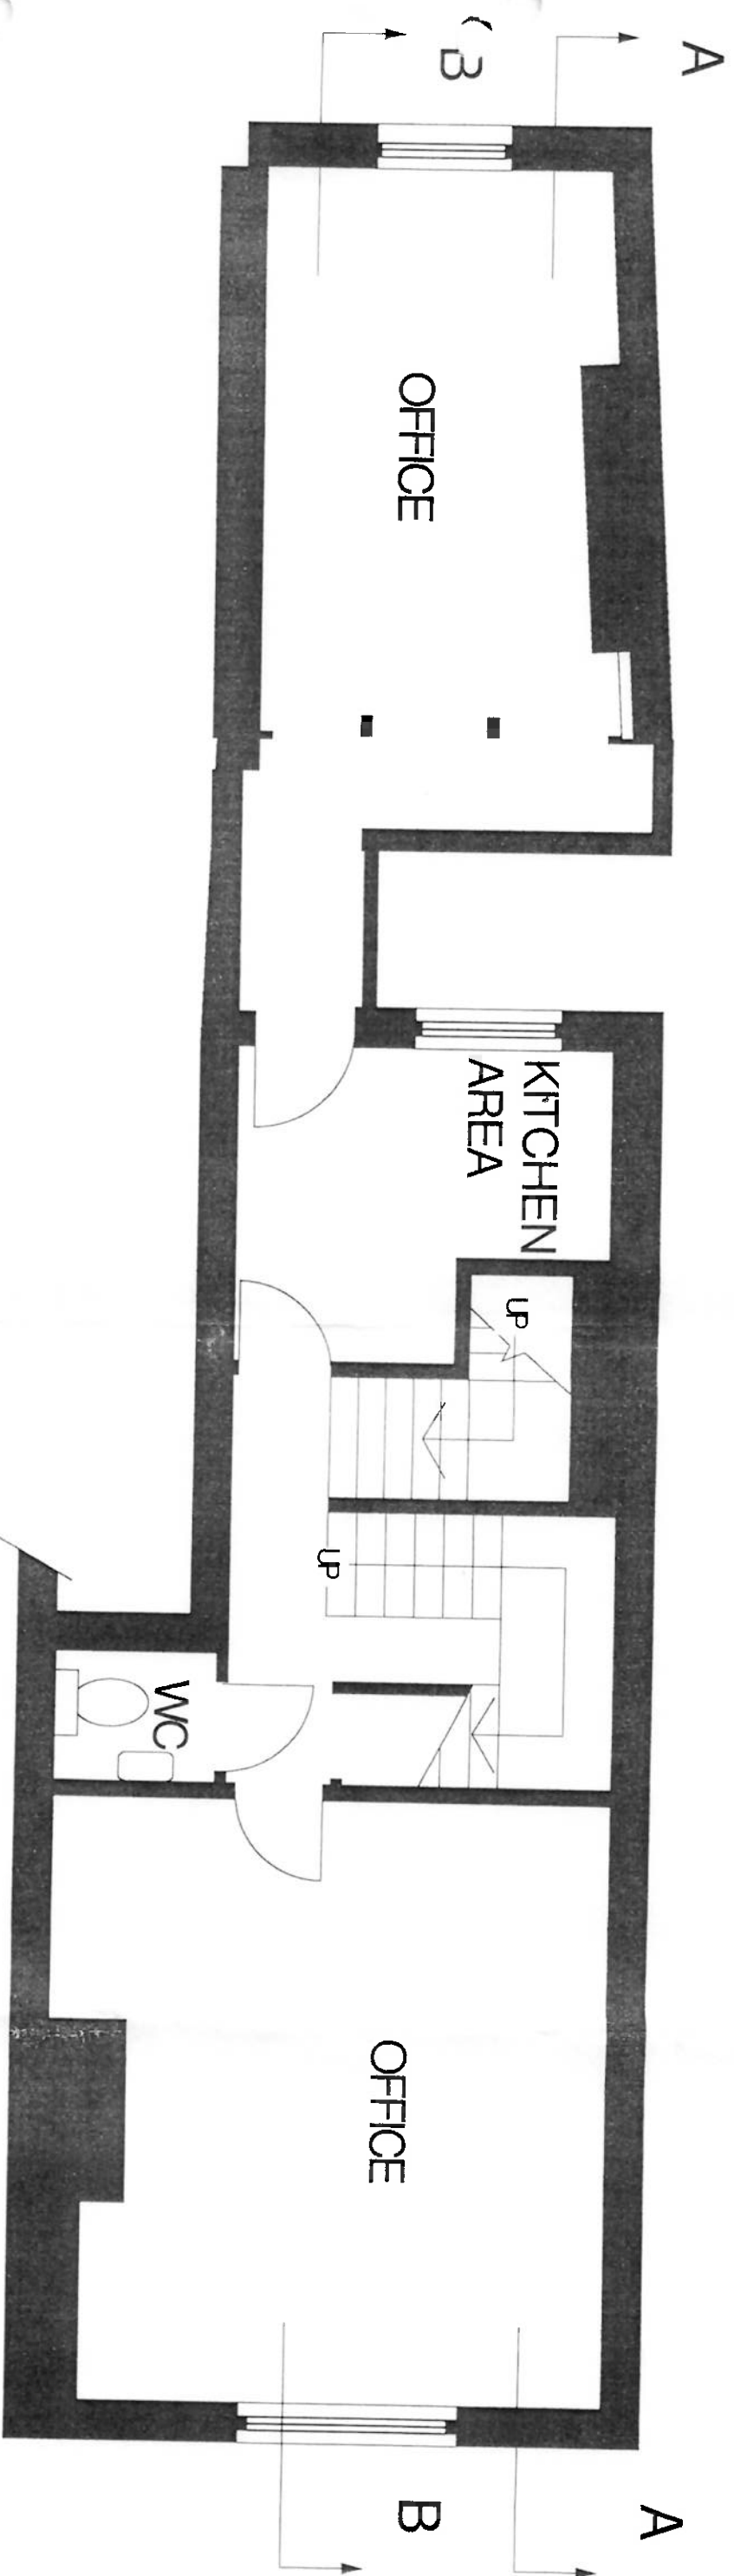

**FIELDWORK**  
DESIGN CONSULTANTS

PROSPECT PLACE  
HEATHFIELD TERRACE  
LONDON W4 4JE

Email fieldwork.co.uk  
FAX +44 (0)181 747 1560  
TEL +44 (0)181 994 9246

SCALES: 1:50

DRAWN BY: DOF

DATE: 1.3.99

DRAWING NUMBER:

1206/00


PROJECT:

HAMPTONS INTERNATIONAL, 27 EAST STREET, CHICHESTER

DRAWING TITLE:

EXISTING PLANS FIRST FLOOR PLANS

NOTES: Dimensions shall not be scaled from this drawing. All figured dimensions must be verified on site. Discrepancies are to be notified immediately to the designers.

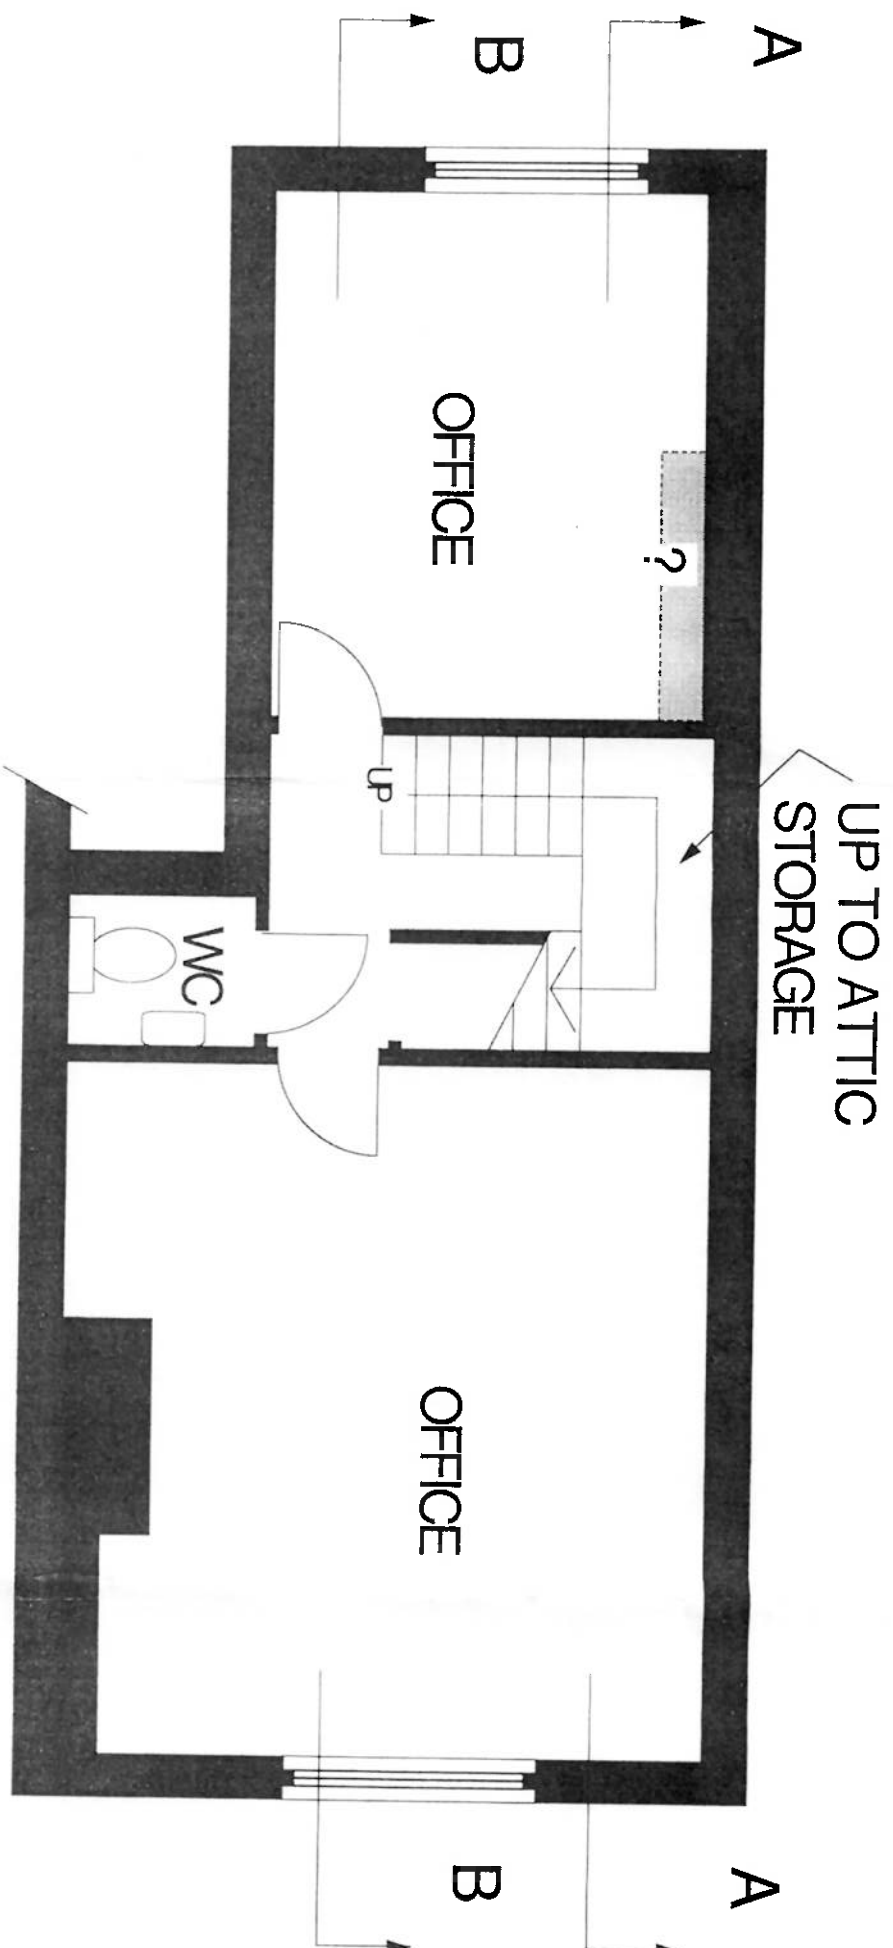

**FIELDWORK**  
DESIGN CONSULTANTS

PROSPECT PLACE  
HEATHFIELD TERRACE  
LONDON W4 4JE

Email fieldwork.co.uk  
FAX +44 (0)181 747 1560  
TEL +44 (0)181 994 9246

SCALES: 1:50  
DRAWN BY: DOF  
DATE: 1.3.99

DRAWING NUMBER: 1206/11



PROJECT:

HAMPTONS INTERNATIONAL, 27 EAST STREET, CHICHESTER

DRAWING TITLE:

EXISTING SECOND FLOOR PLAN

NOTES: Dimensions shall not be scaled from this drawing. All figured dimensions must be verified on site. Discrepancies are to be notified immediately to the designers.

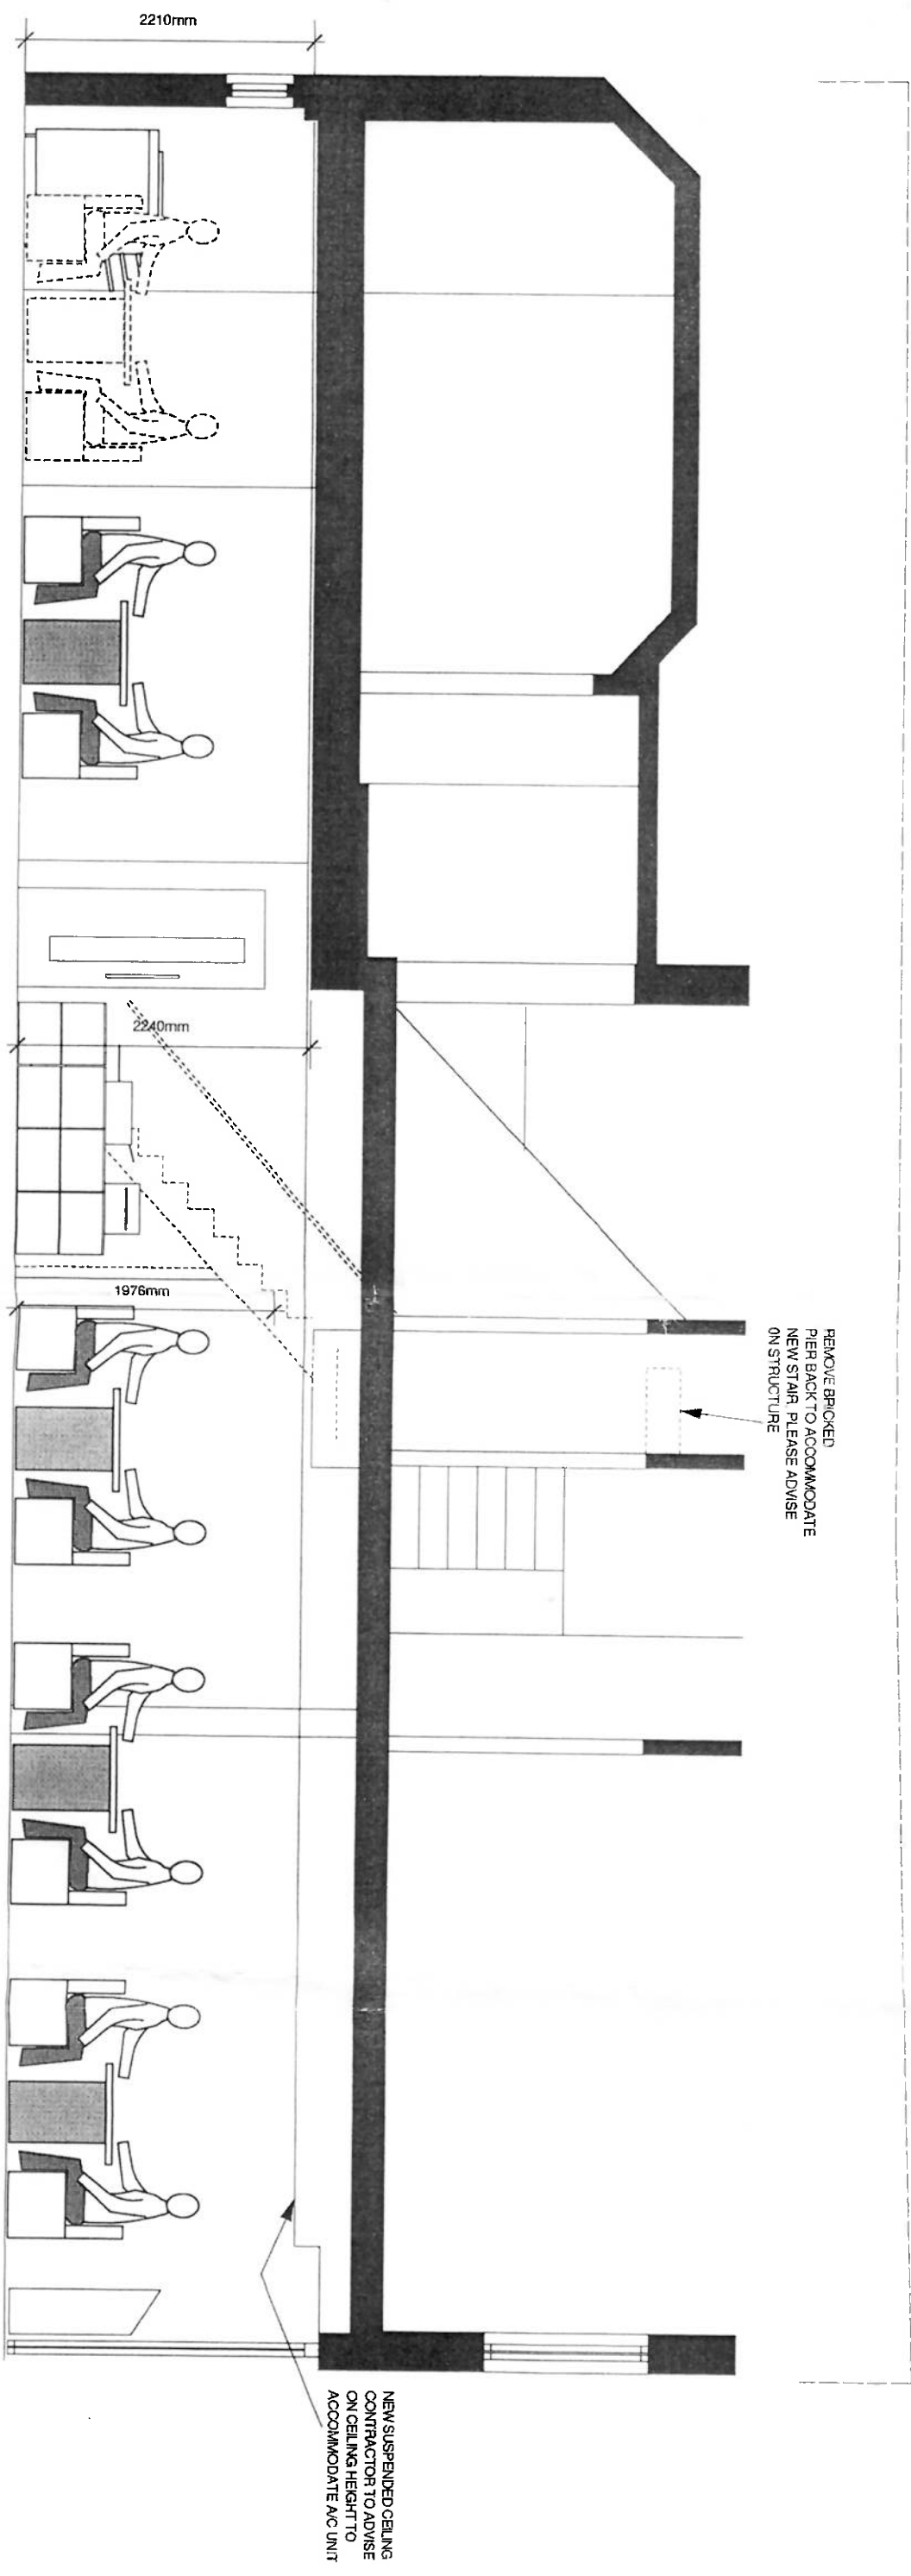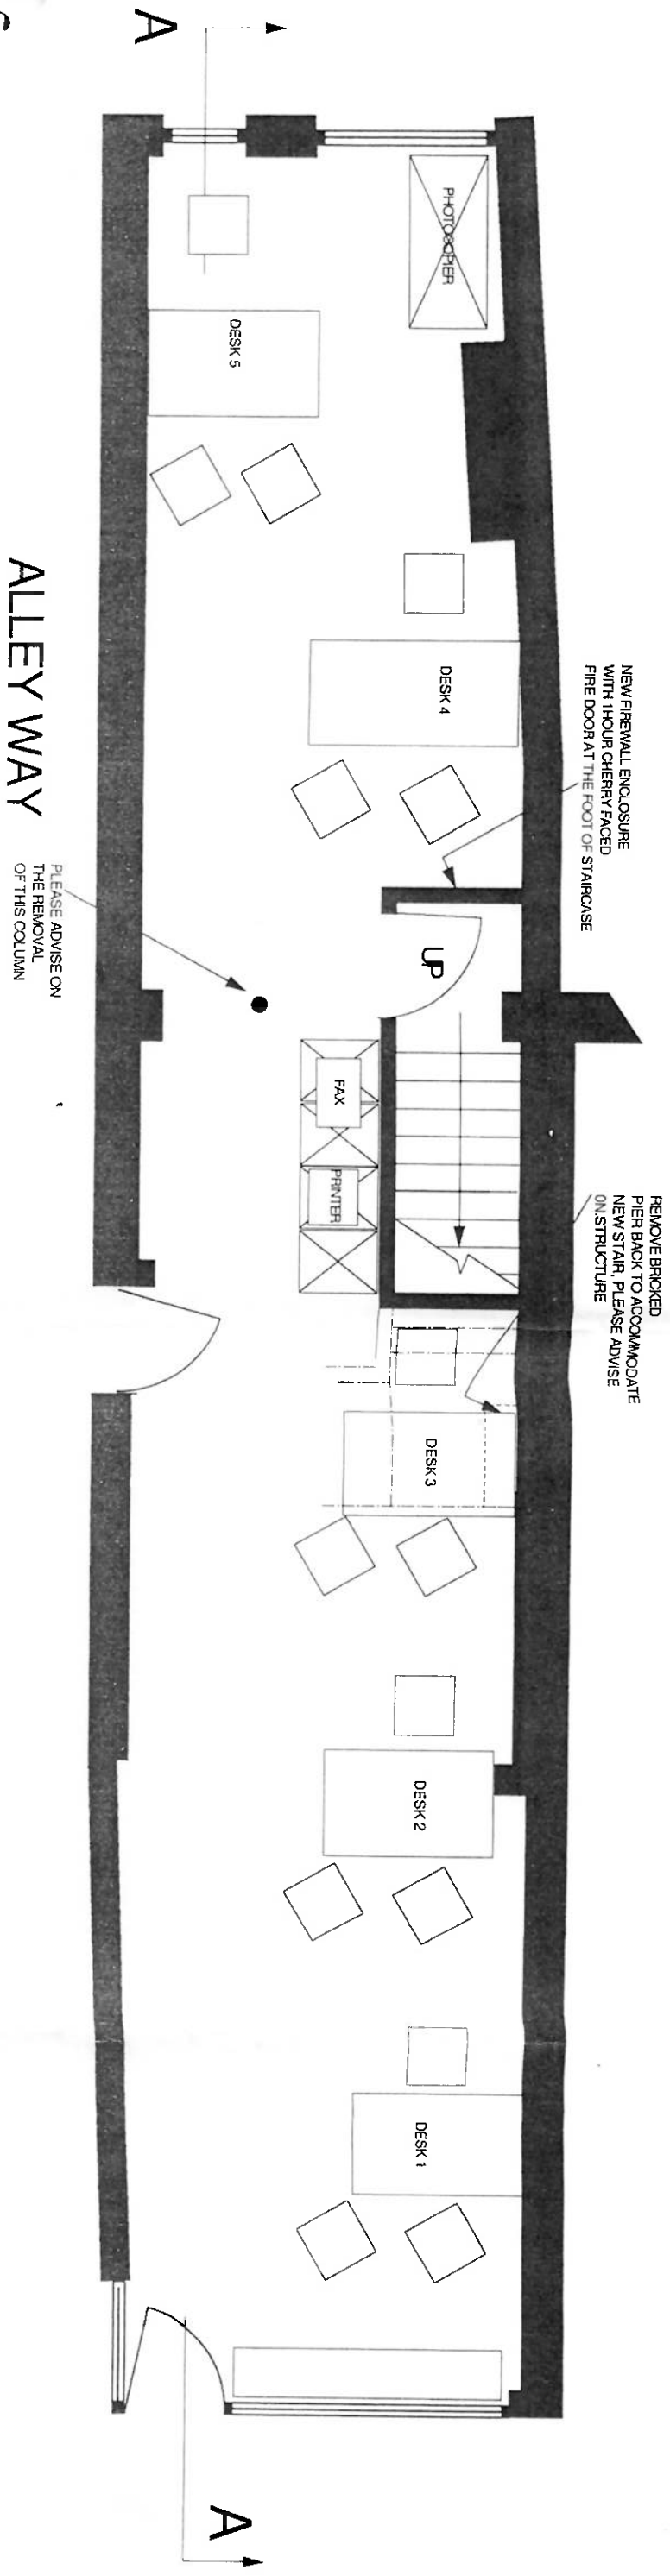

**FIELDWORK**  
DESIGN CONSULTANTS

PROSPECT PLACE  
HEATHFIELD TERRACE  
LONDON W4 4JE

Email fieldwork.co.uk  
FAX +44 (0)181 747 1560  
TEL +44 (0)181 994 9246

SCALES: 1:50  
DRAWN BY: KH  
DATE: 19.2.99

PROJECT: HAMPTONS INTERNATIONAL, 27 EAST STREET, CHICHESTER

NOTES: Dimensions shall not be scaled from this drawing. All figured dimensions must be verified on site. Discrepancies are to be notified immediately to the designers